




# LAURELTON COMMUNITY LIBRARY RENOVATION

## PRESENTATION TO COMMUNITY BOARD 13Q



DIVISION OF PUBLIC BUILDINGS

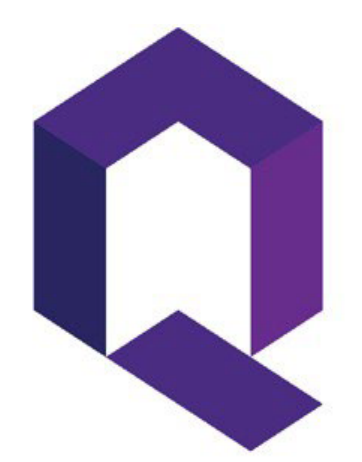


QUEENS PUBLIC LIBRARY



RICARDO ZURITA ARCHITECTURE & PLANNING P.C.  
15 East 40th Street, Suite 900, New York, NY 10016  
(212) 685-2910 | [www.rzaps.com](http://www.rzaps.com)




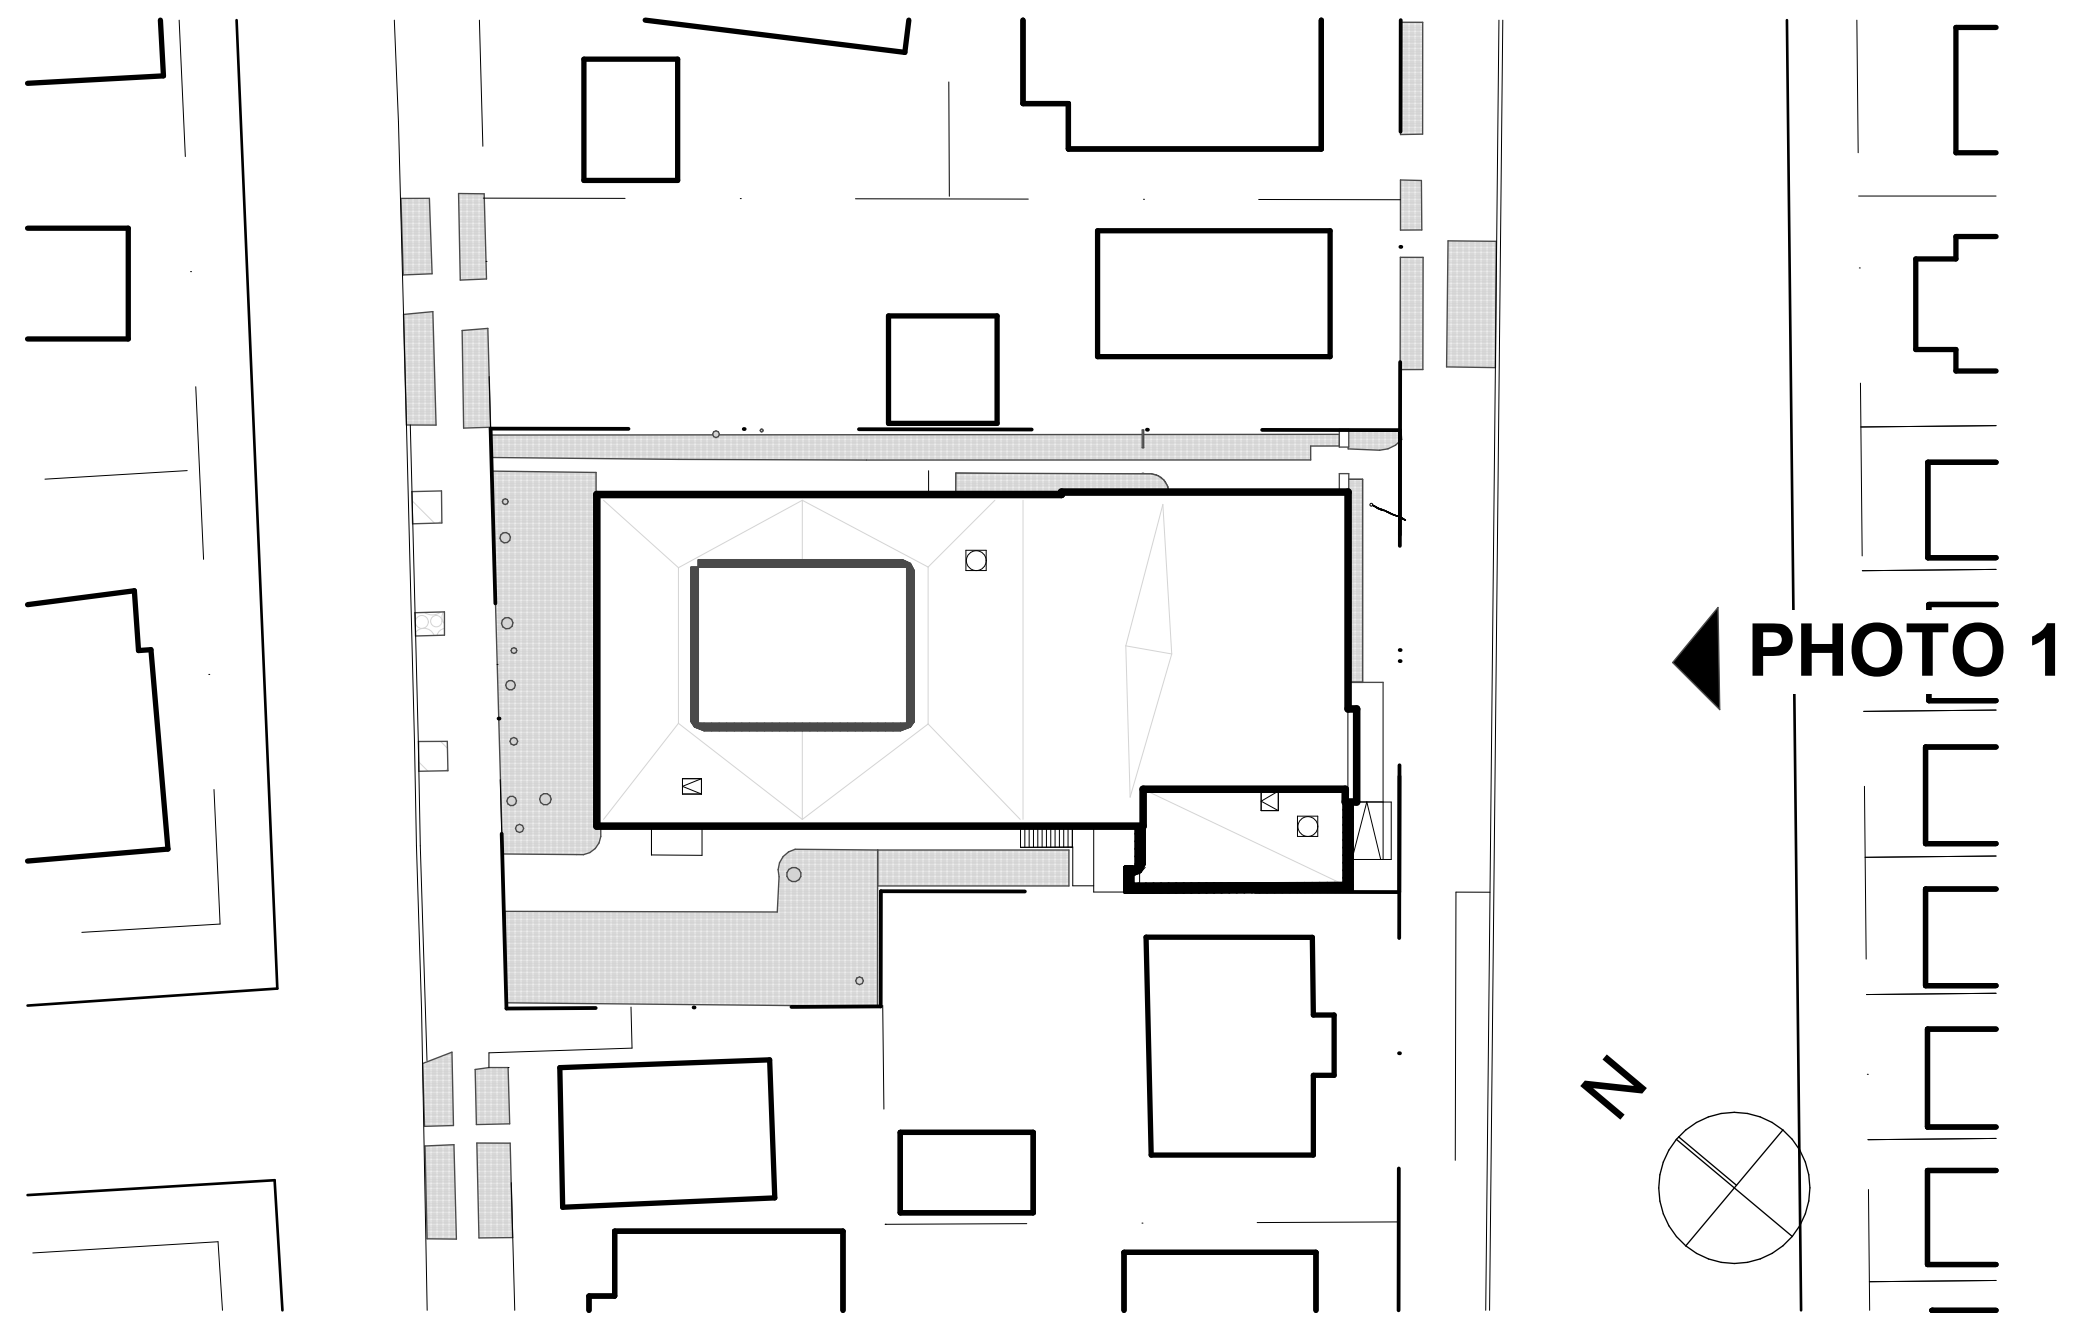

2 KEYPLAN  
NOT TO SCALE



1 PHOTO 1  
NOT TO SCALE

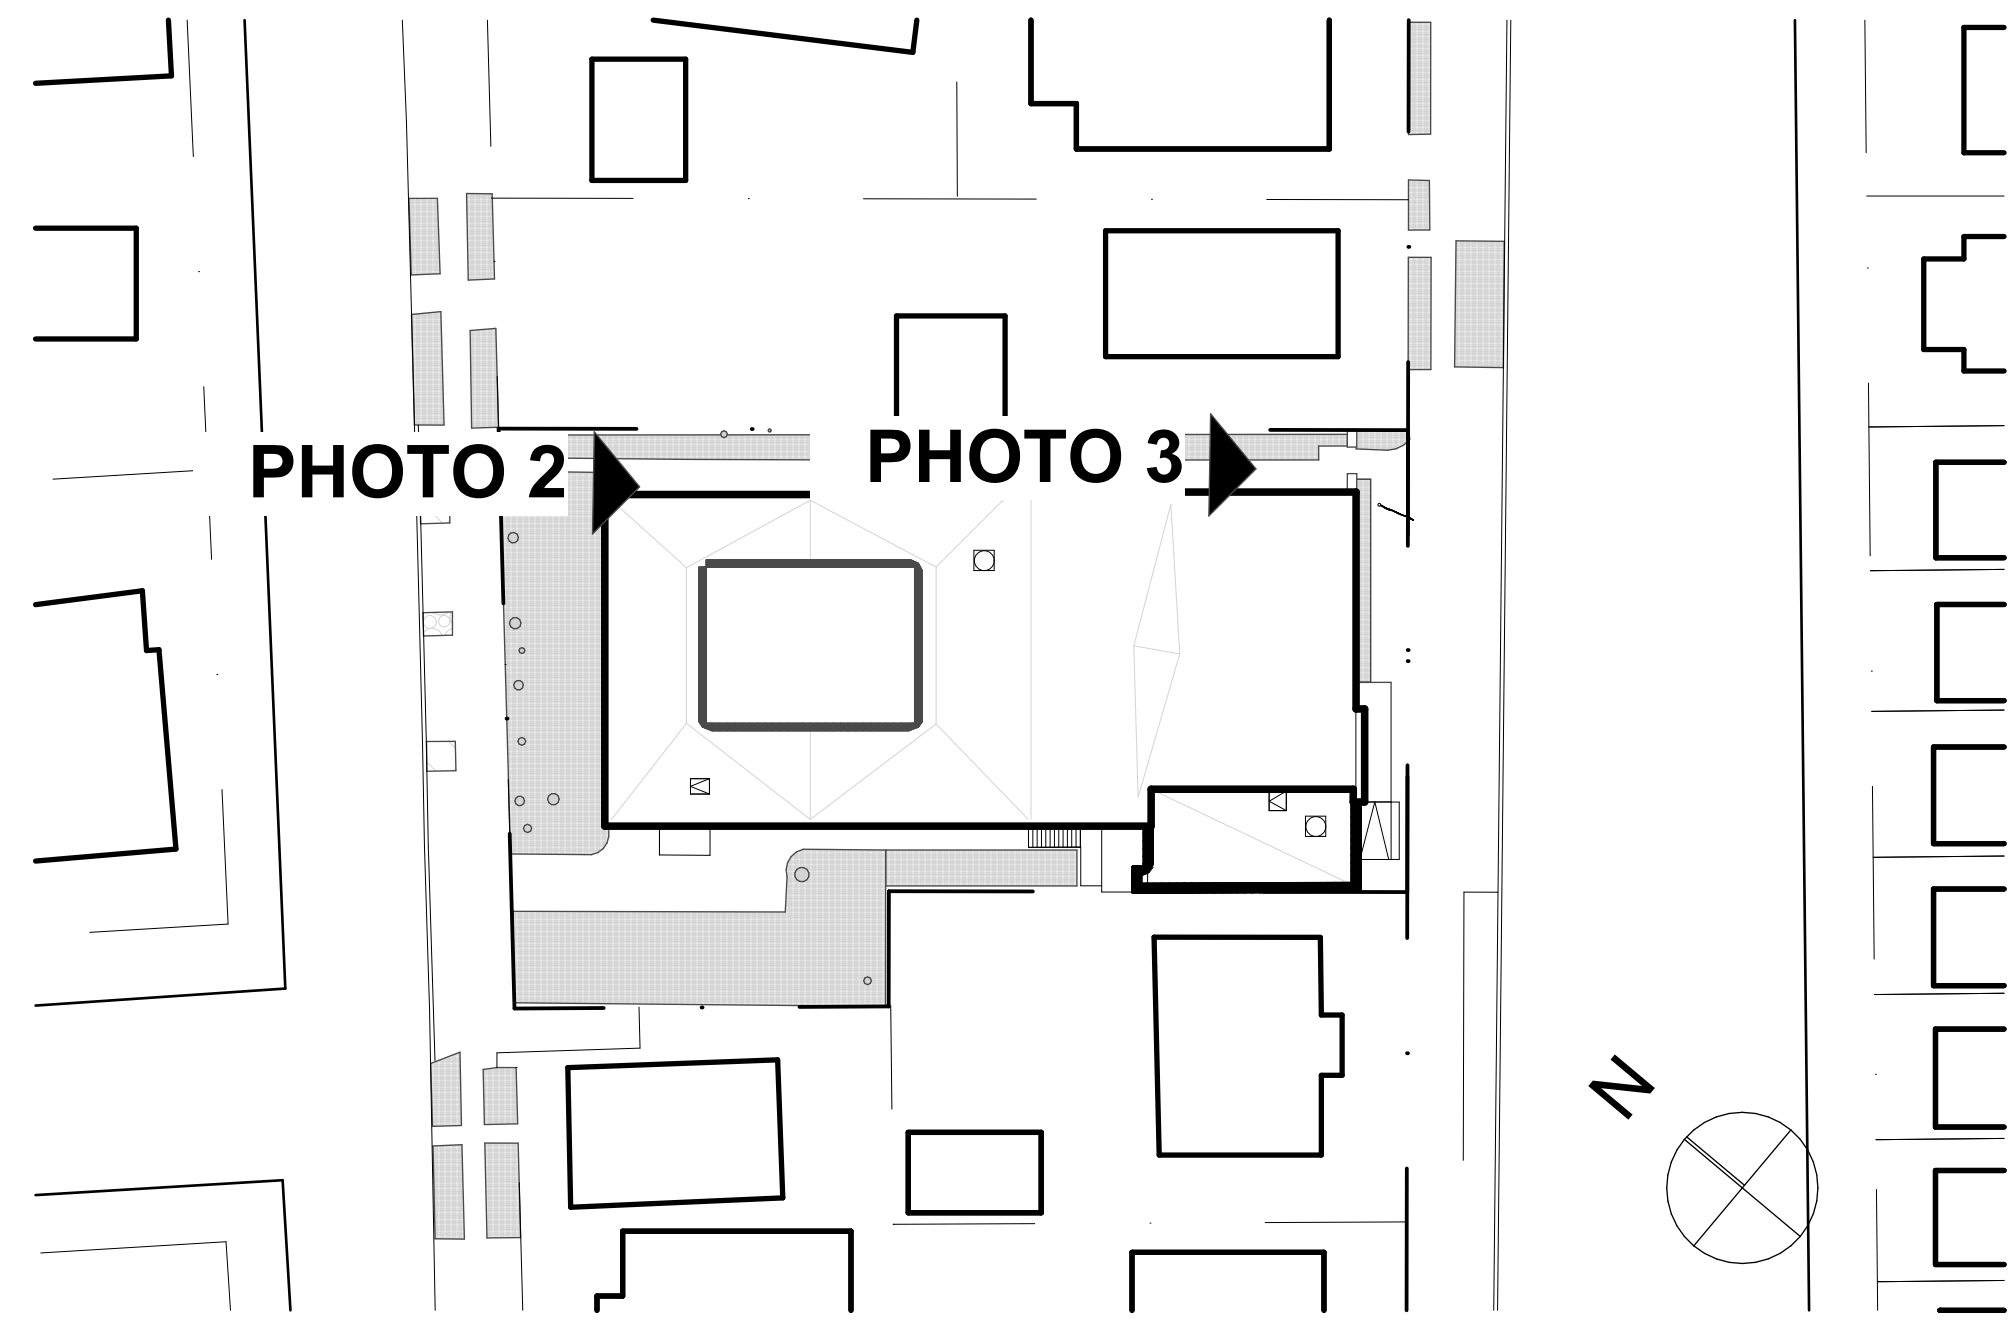


3 KEYPLAN  
NOT TO SCALE



1 PHOTO 2  
NOT TO SCALE



2 PHOTO 3  
NOT TO SCALE

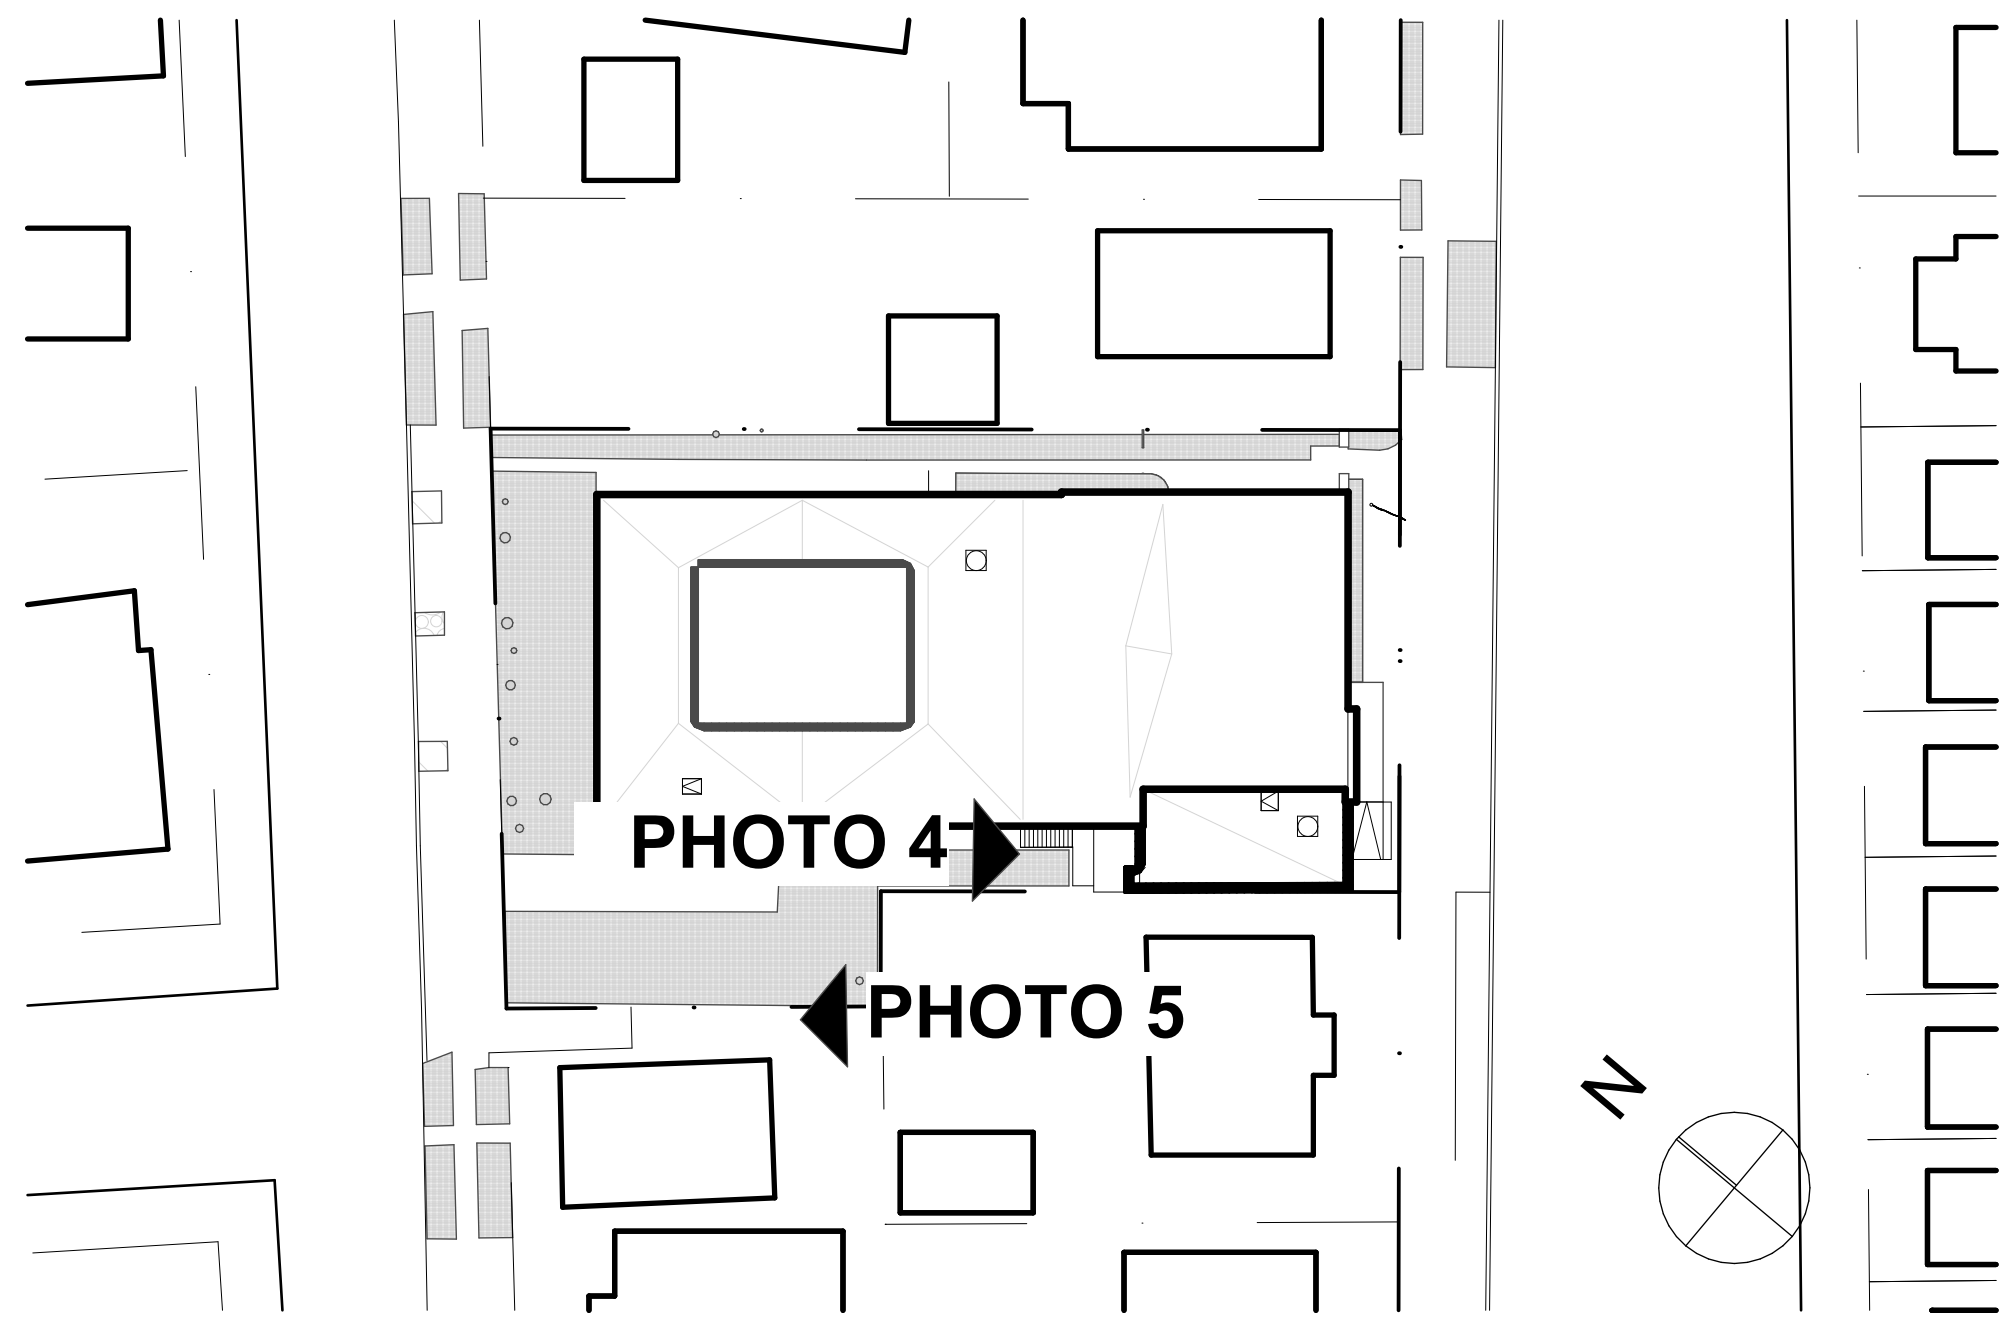


3 KEYPLAN  
NOT TO SCALE



1 PHOTO 4  
NOT TO SCALE



2 PHOTO 5  
NOT TO SCALE

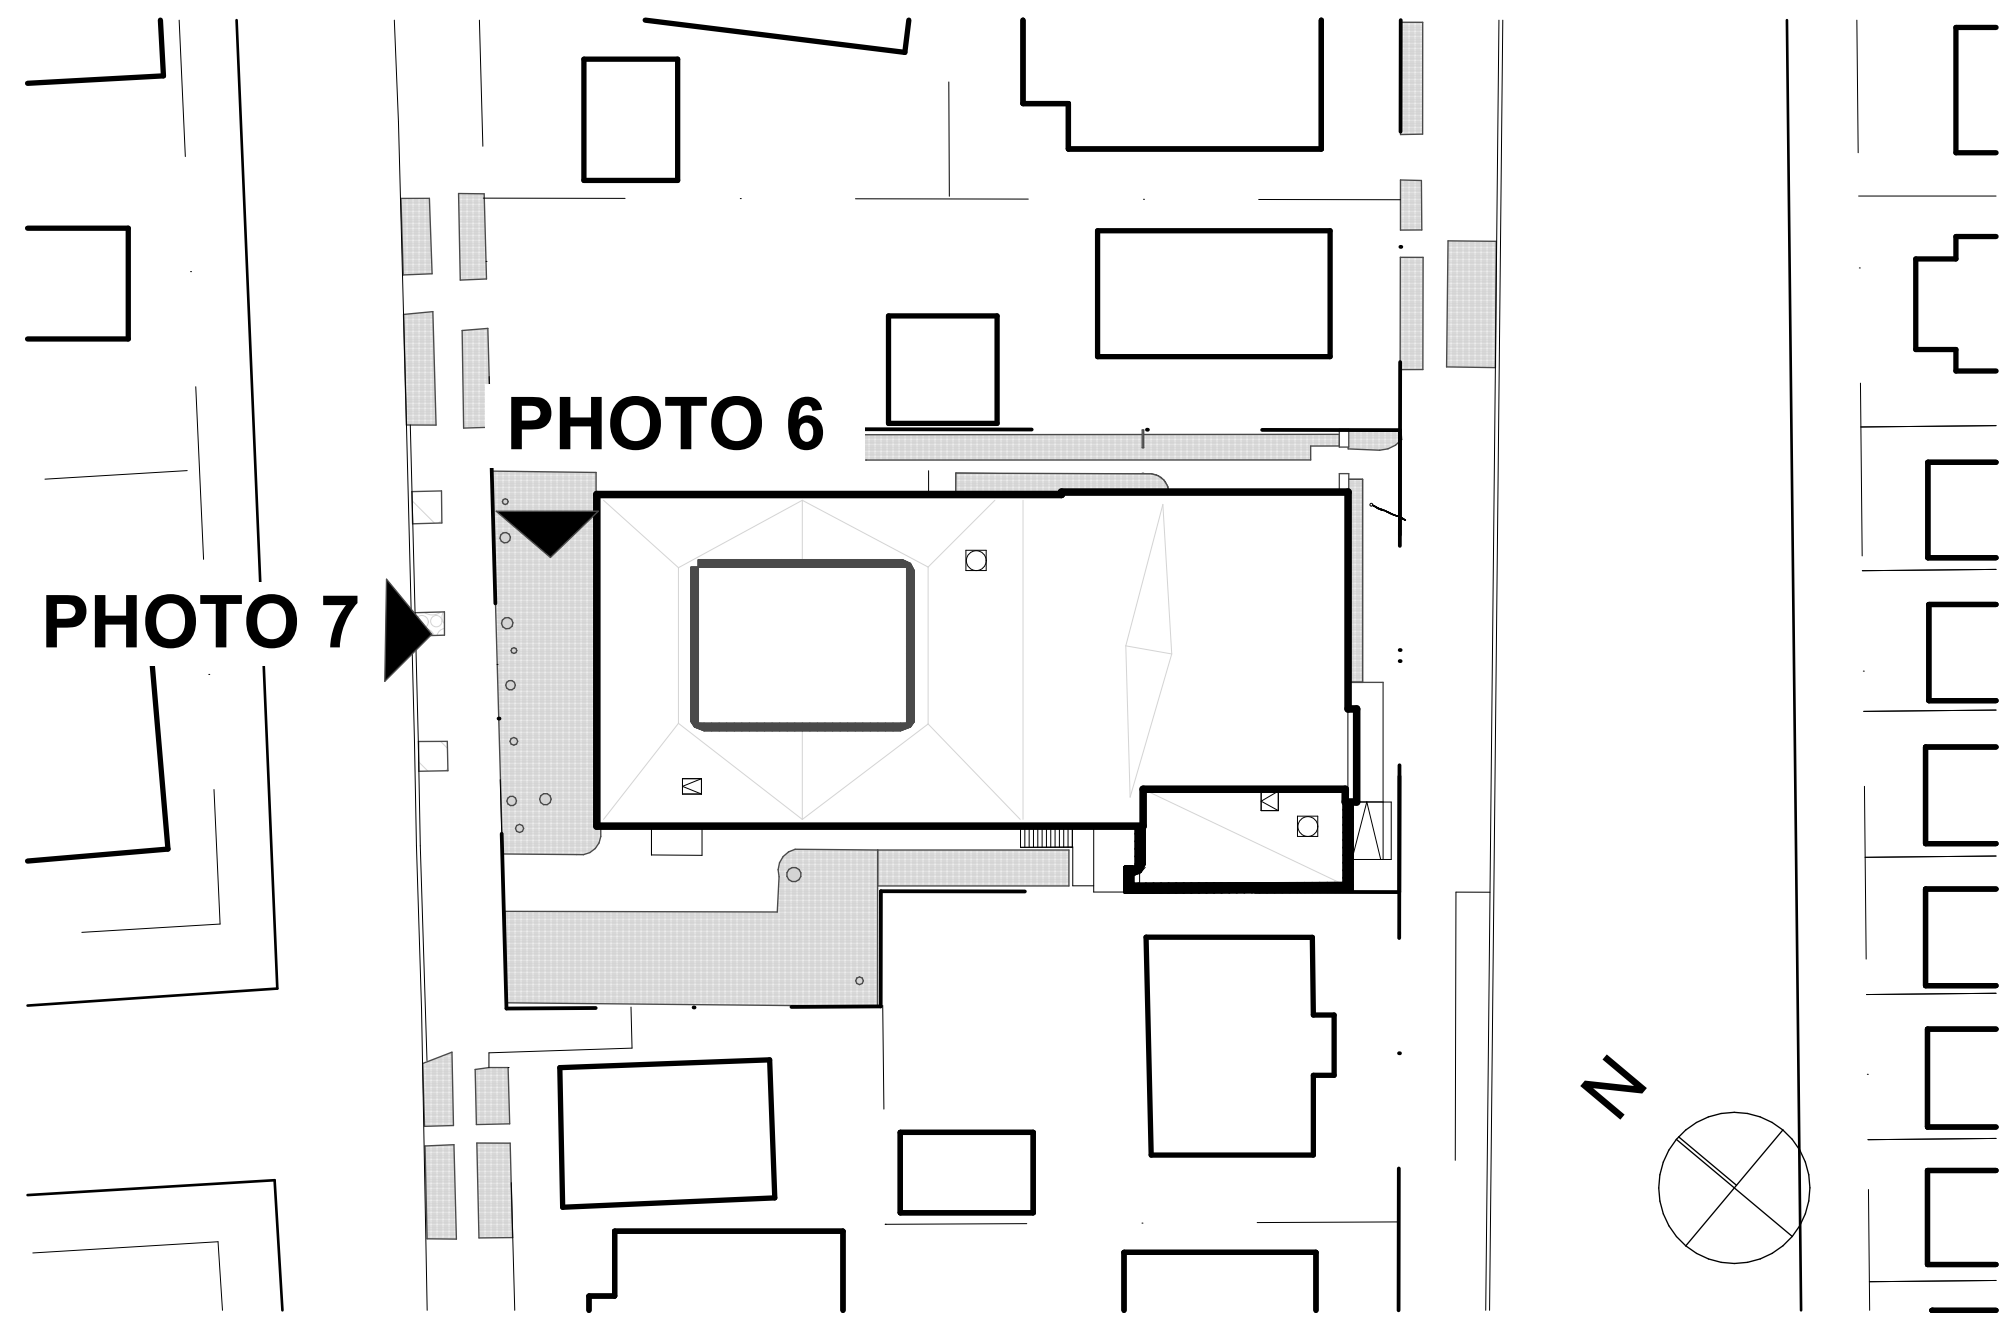


3 KEYPLAN  
NOT TO SCALE




1 PHOTO 6  
NOT TO SCALE



2 PHOTO 7  
NOT TO SCALE

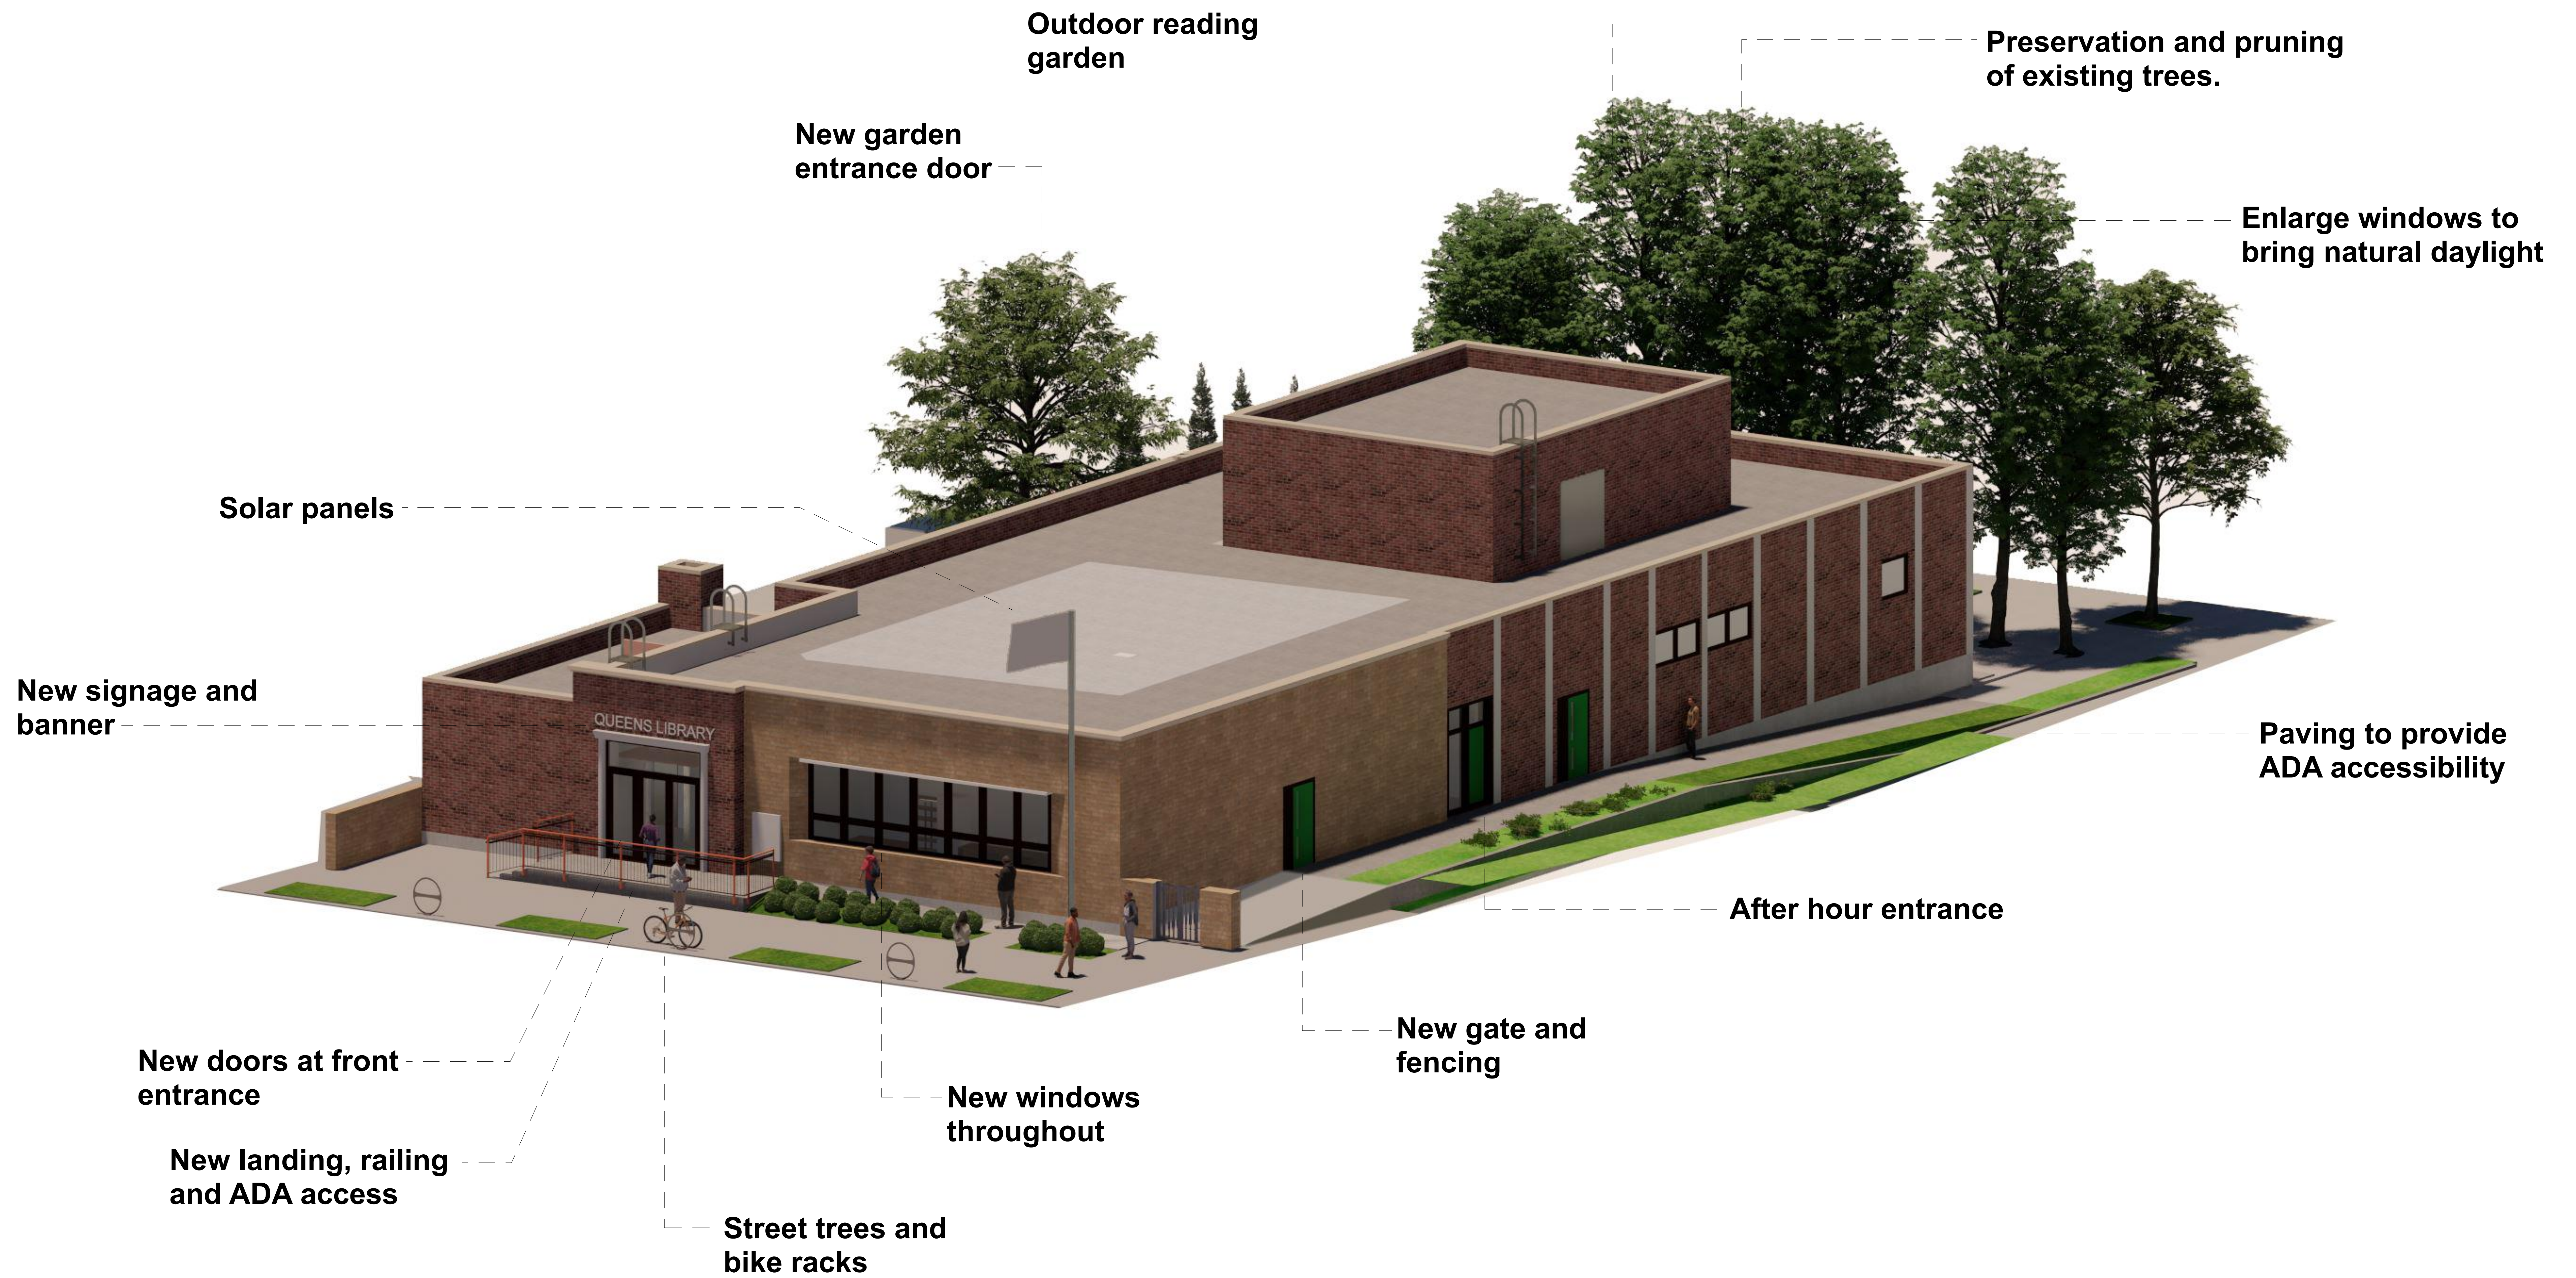


A B C D E F G

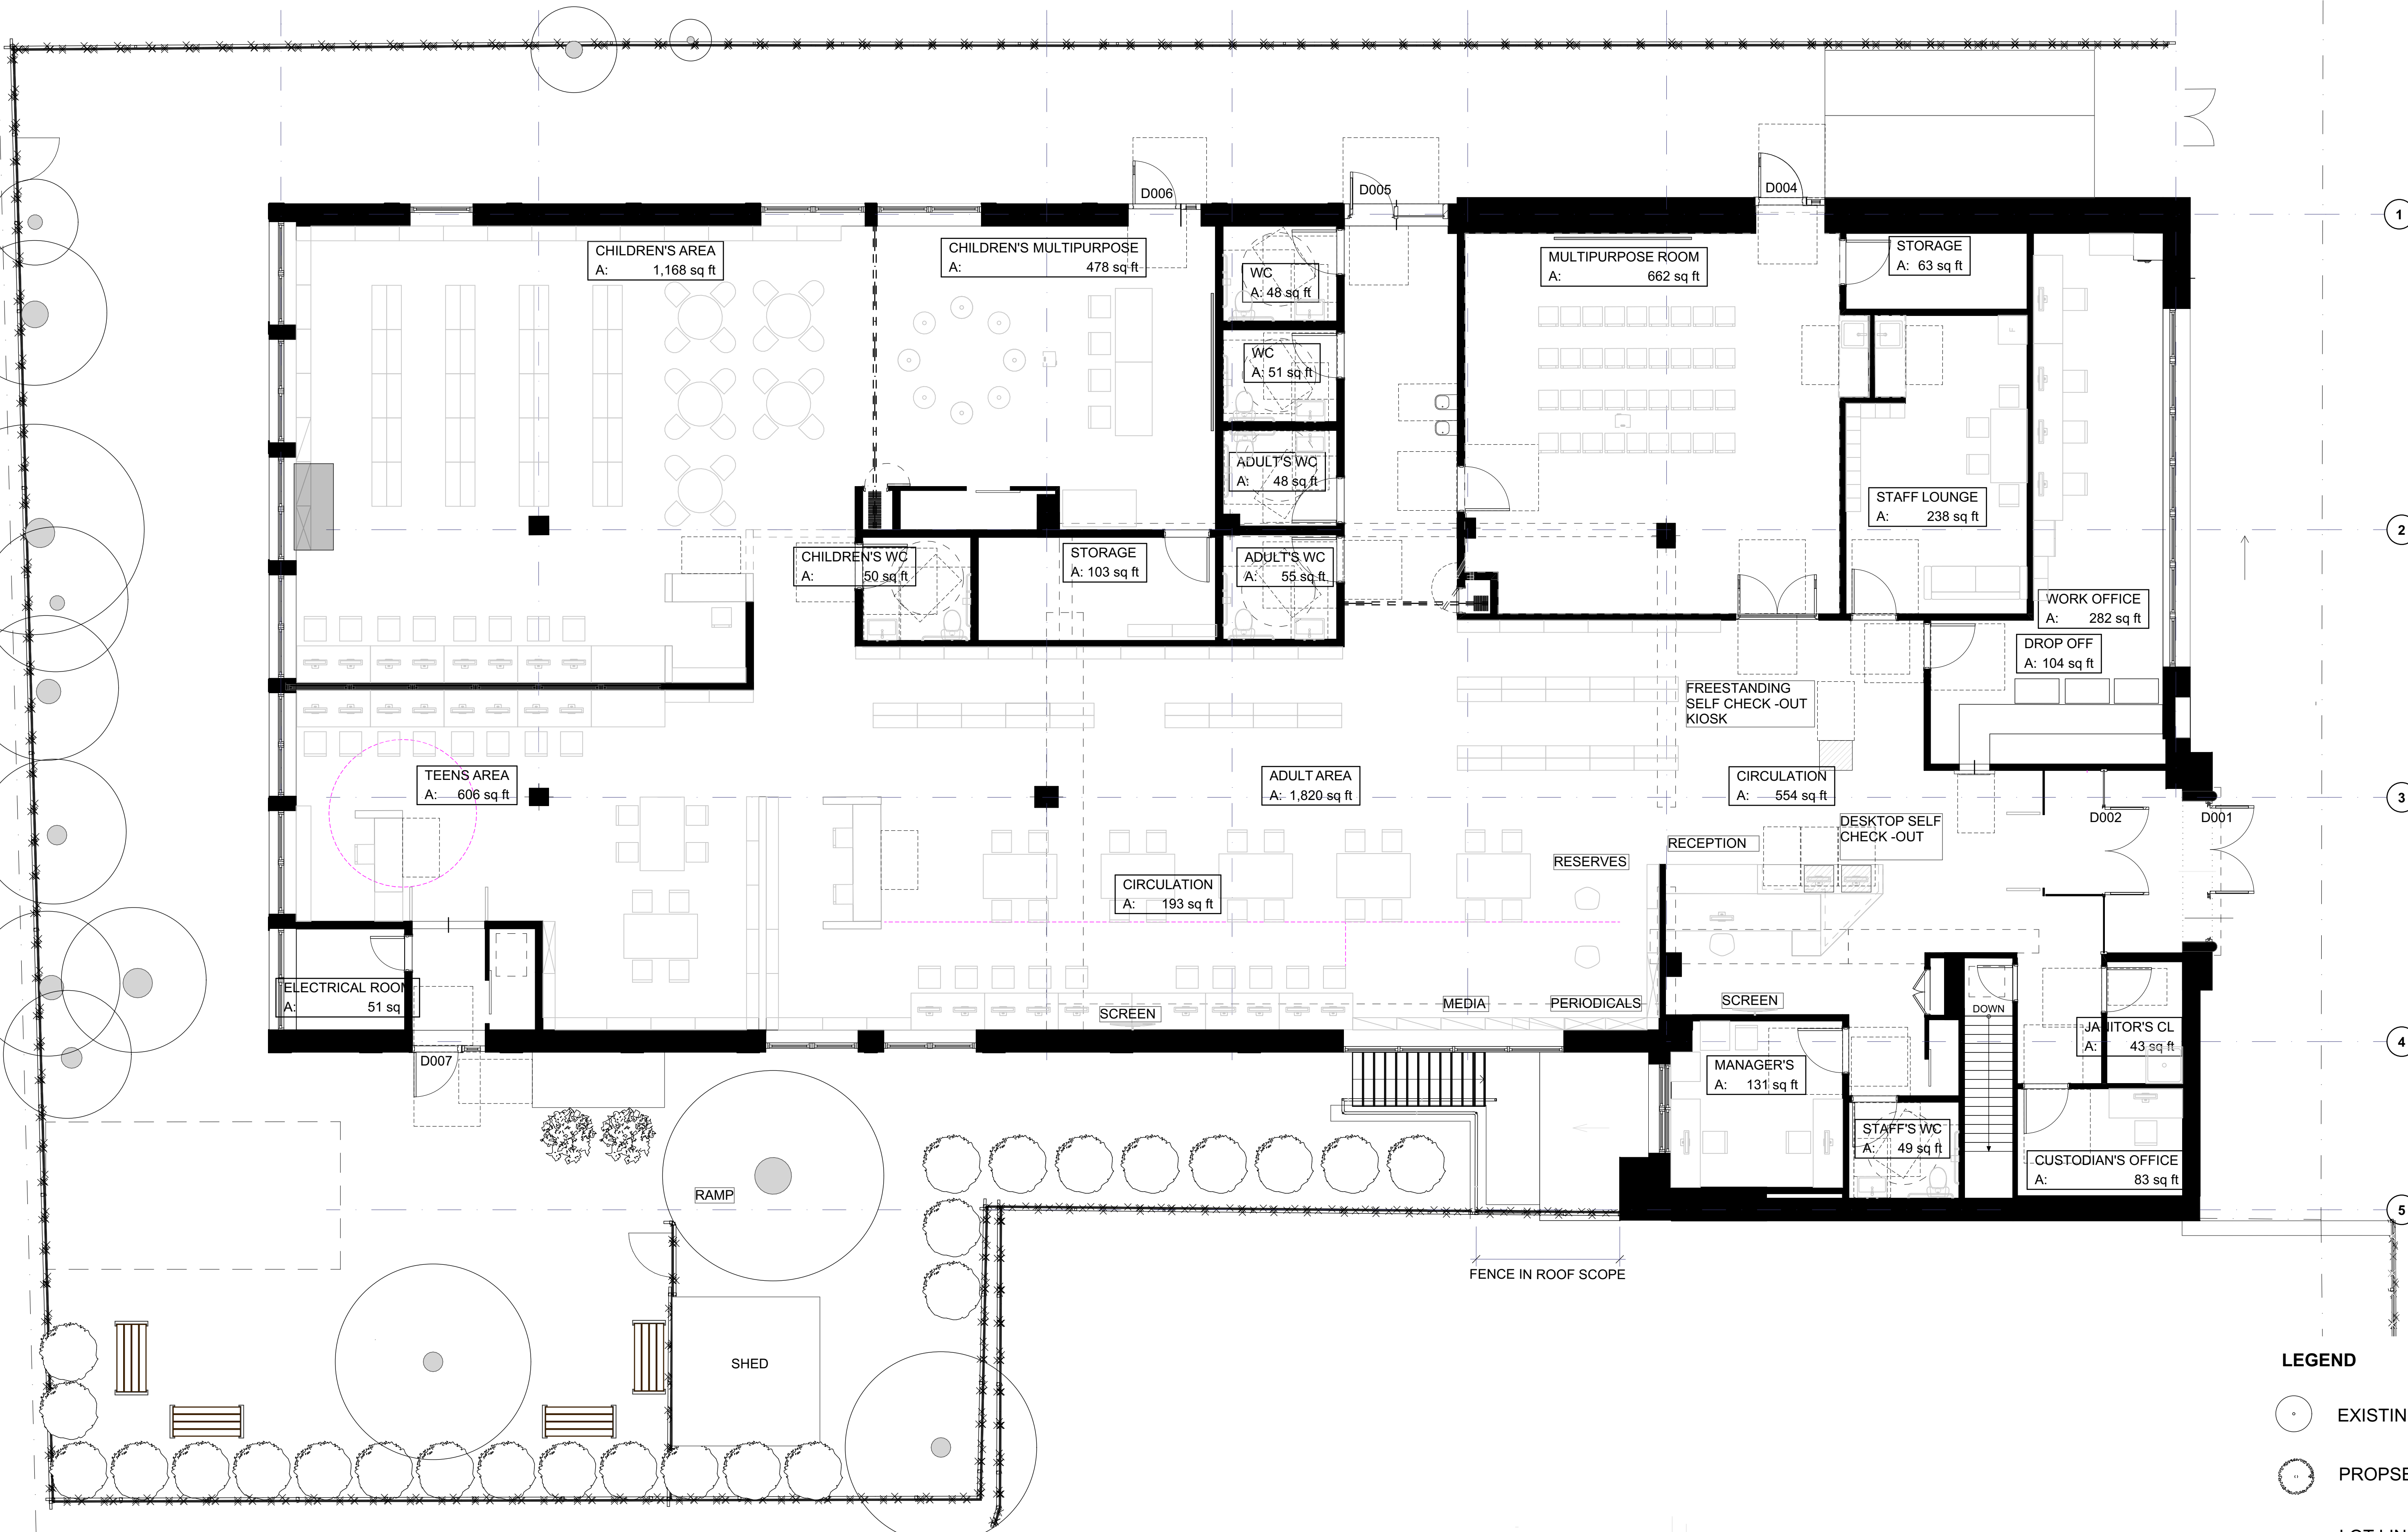

PRELIMINARY FLOOR PLAN

- LEGEND**
- EXISTING TREE
  - PROPOSED TREE
  - - - LOT LINE

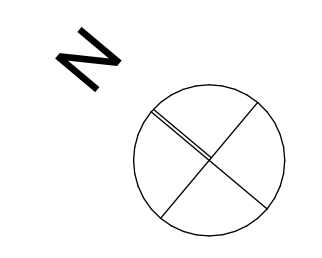

1 PROPOSED PLAN  
SCALE: 3/16" = 1'-0"






1 PROPOSED EAST ELEVATION  
SCALE: 3/16" = 1'-0"


### WORK SCOPE

1. CONCRETE ADA ACCESS
2. GUARDRAILS AND CONCRETE LANDING
3. CONCRETE STEPS
4. ALUMINUM AND GLASS ENTRANCE
5. ALUMINUM WINDOWS
6. GATE
7. SIGN
8. BANNER

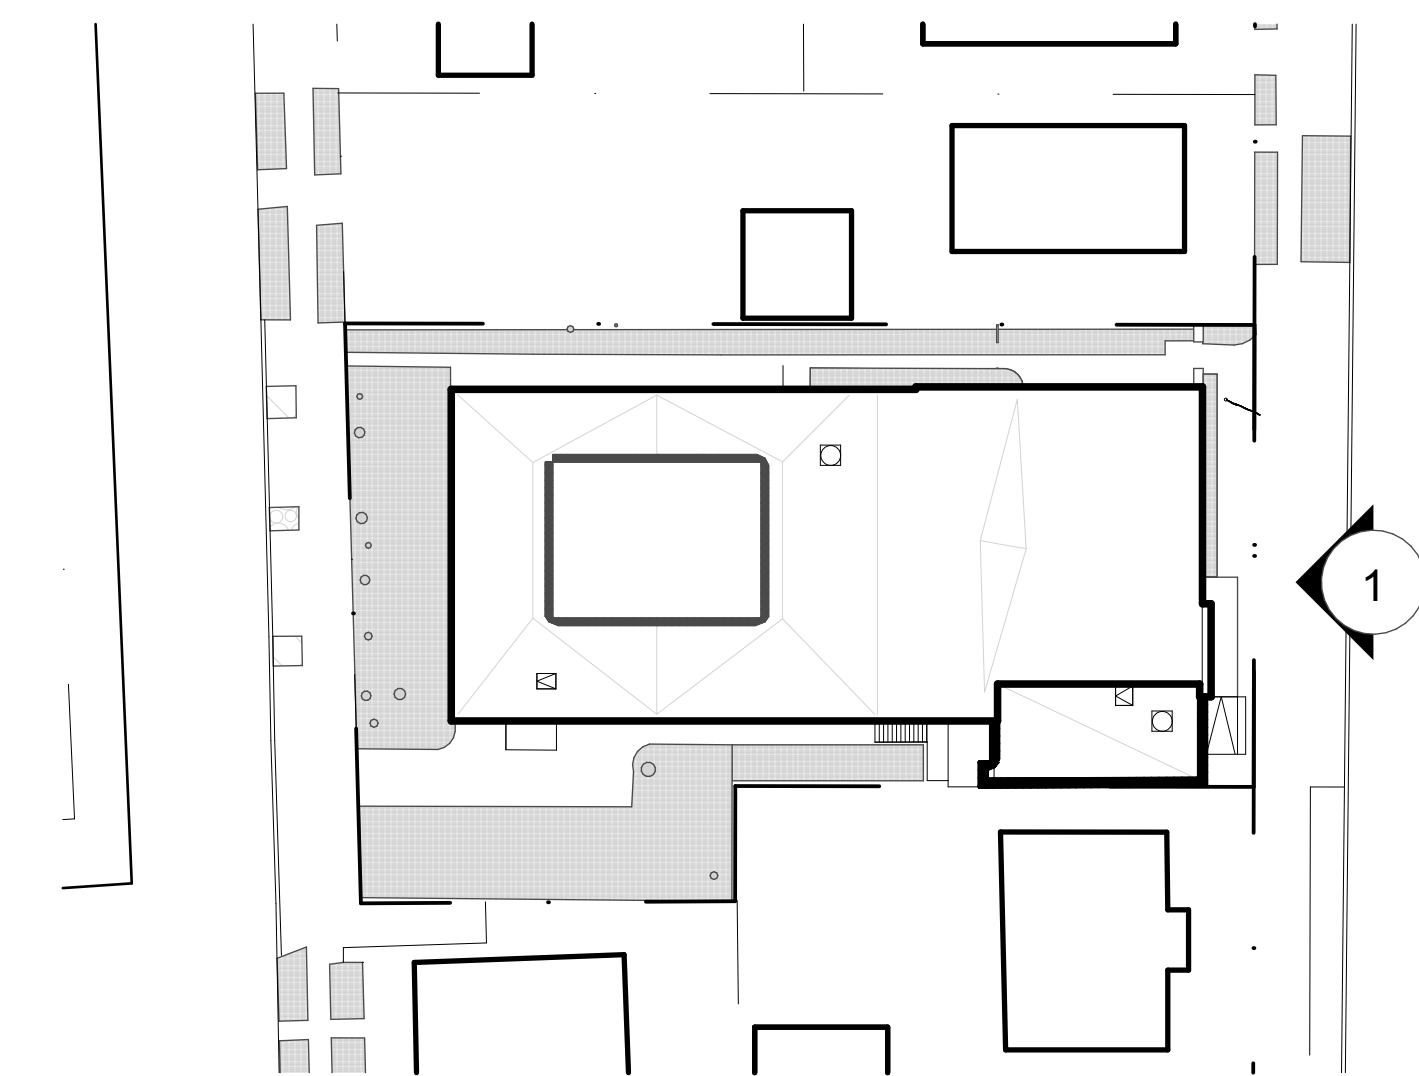

1 KEYPLAN  
NOT TO SCALE




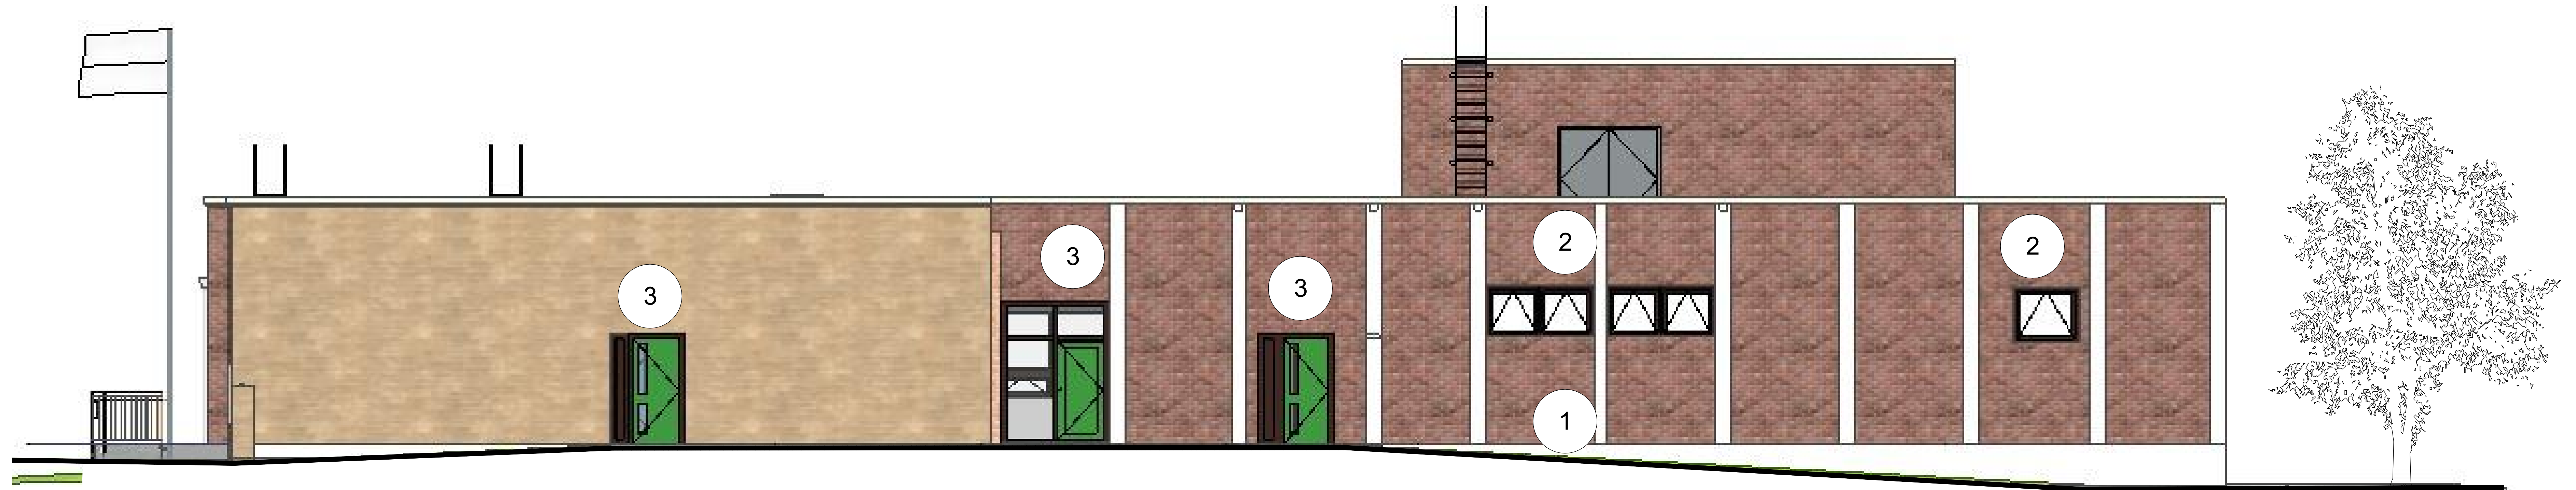

1 PROPOSED NORTH ELEVATION  
SCALE: 3/16" = 1'-0"


### WORK SCOPE

- 1. PATH WITH ADA ACCESS
- 2. ALUMINUM WINDOWS
- 3. STEEL AND GLASS DOORS

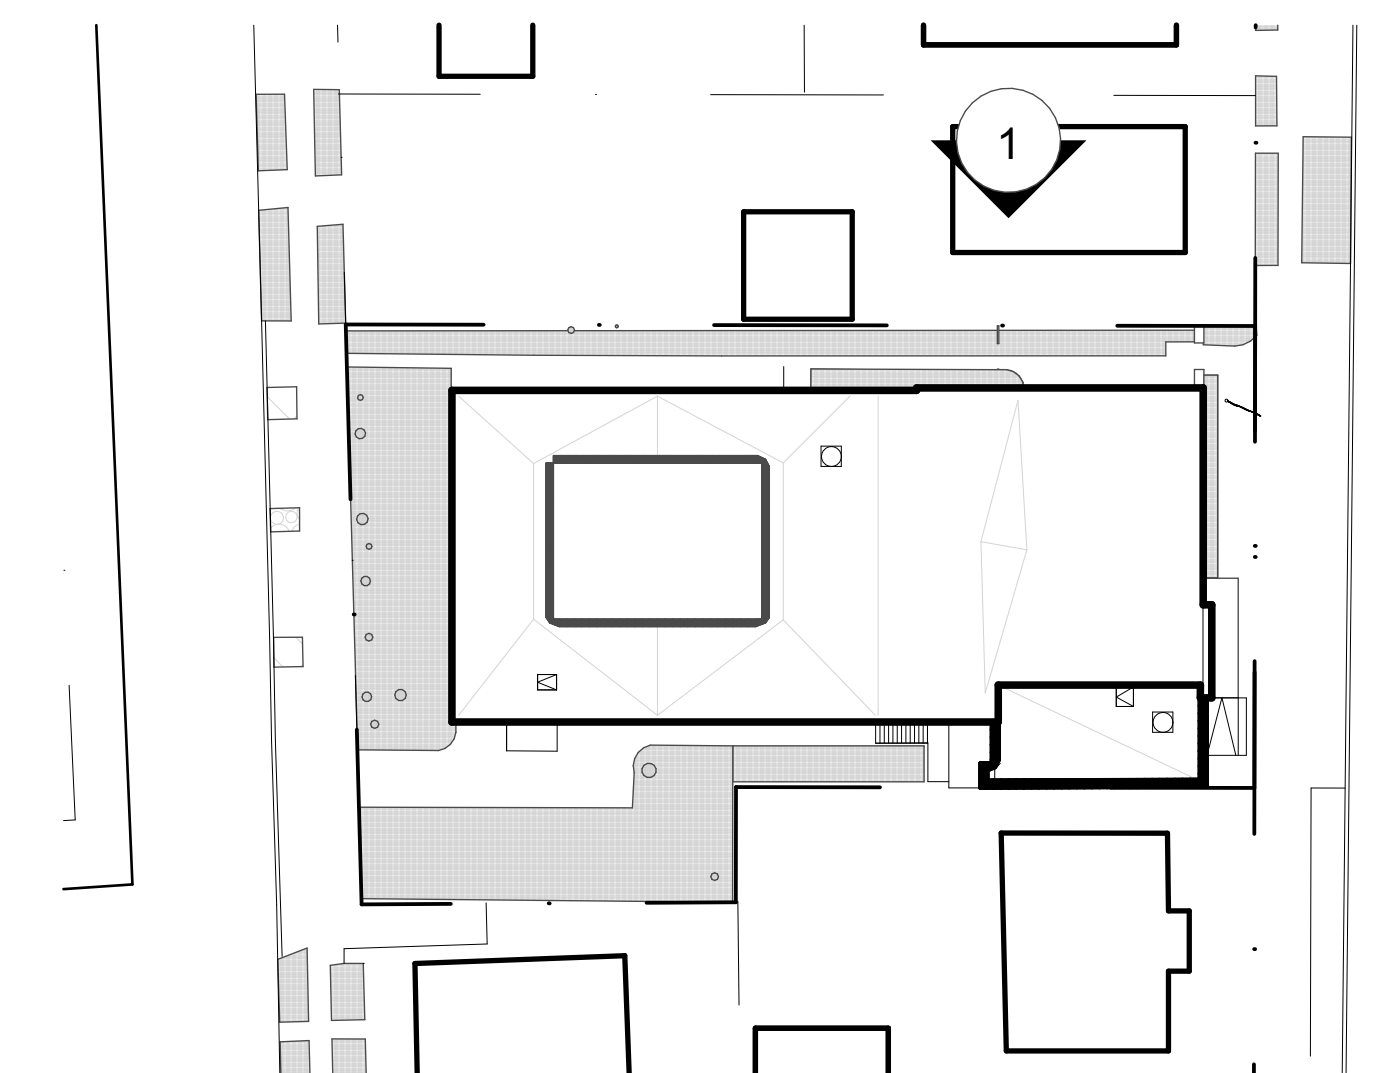

2 KEYPLAN  
NOT TO SCALE




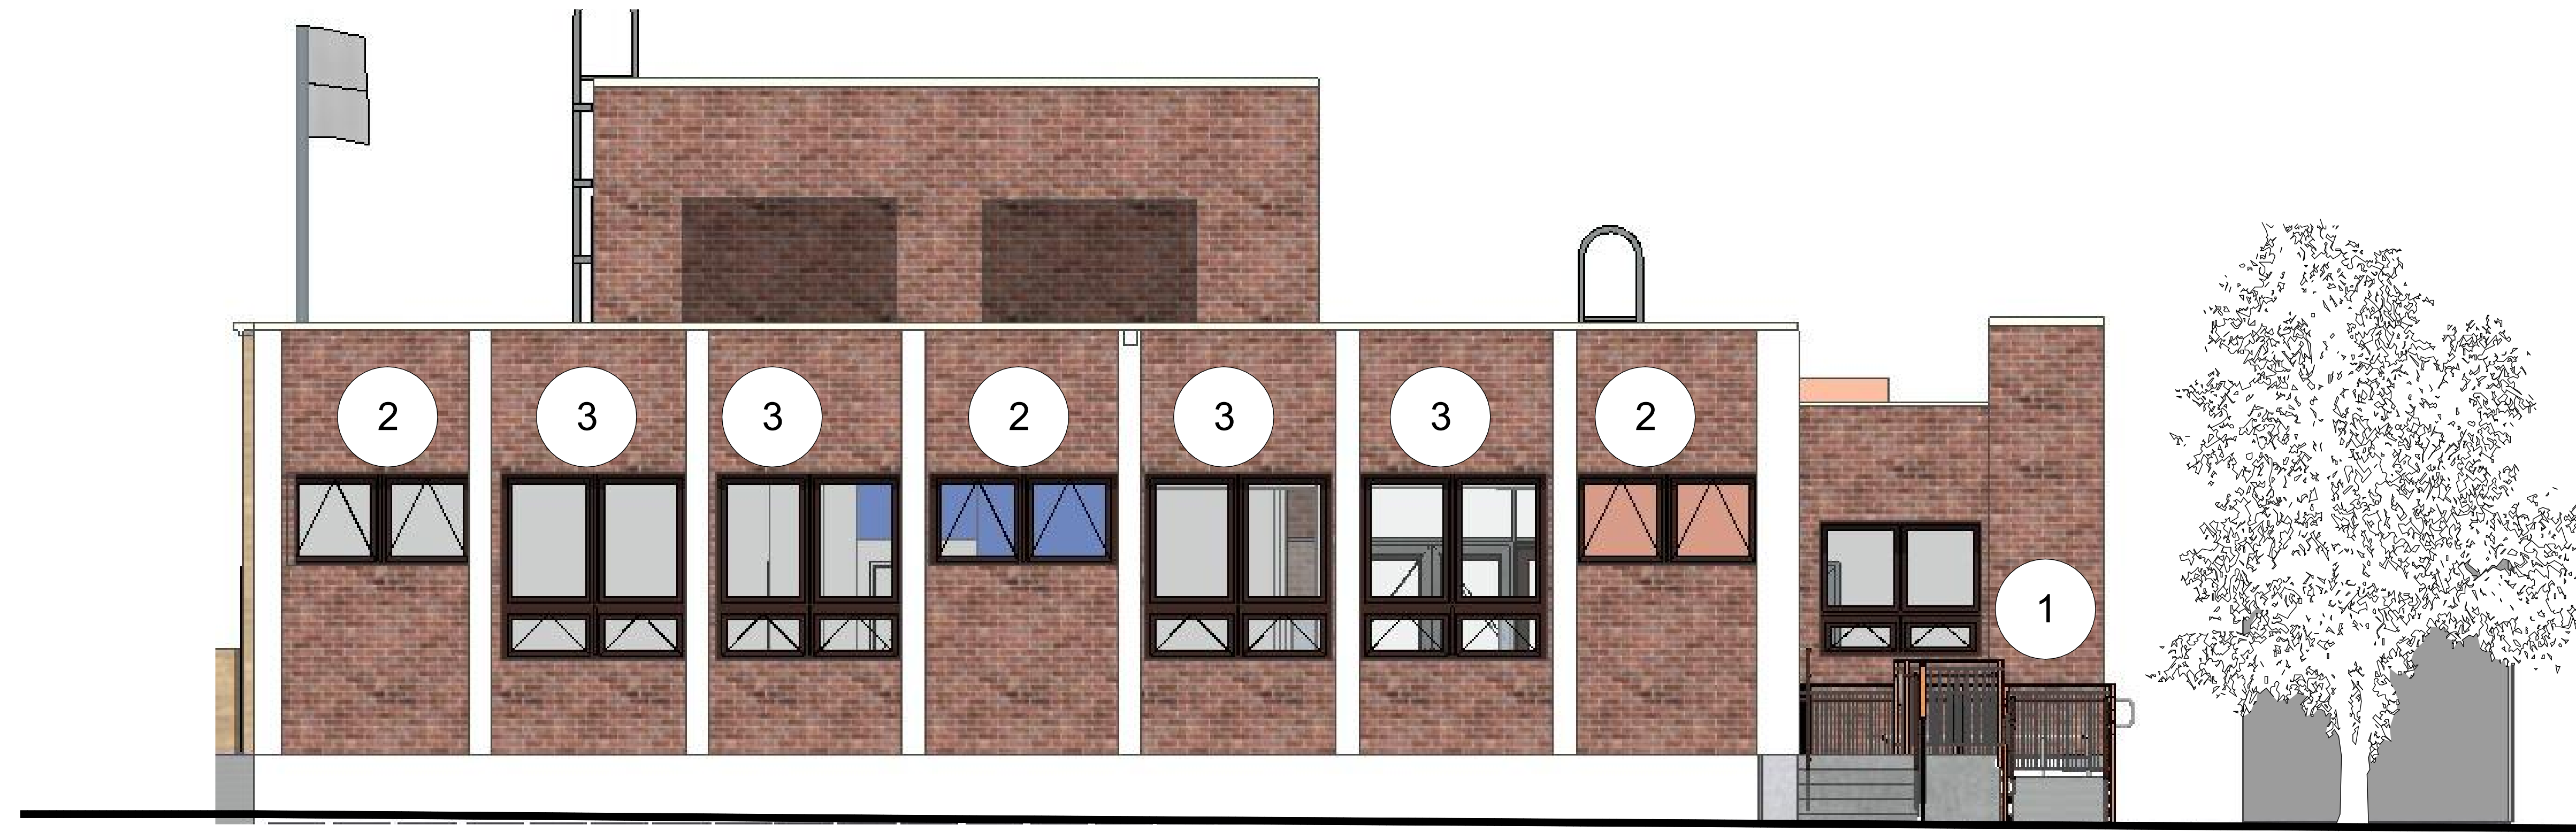

1 PROPOSED WEST ELEVATION  
SCALE: 3/16" = 1'-0"

### WORK SCOPE

1. ADA RAMP WITH LANDING AND METAL RAILING
2. ALUMINUM WINDOWS
3. ENLARGED WINDOW OPENINGS

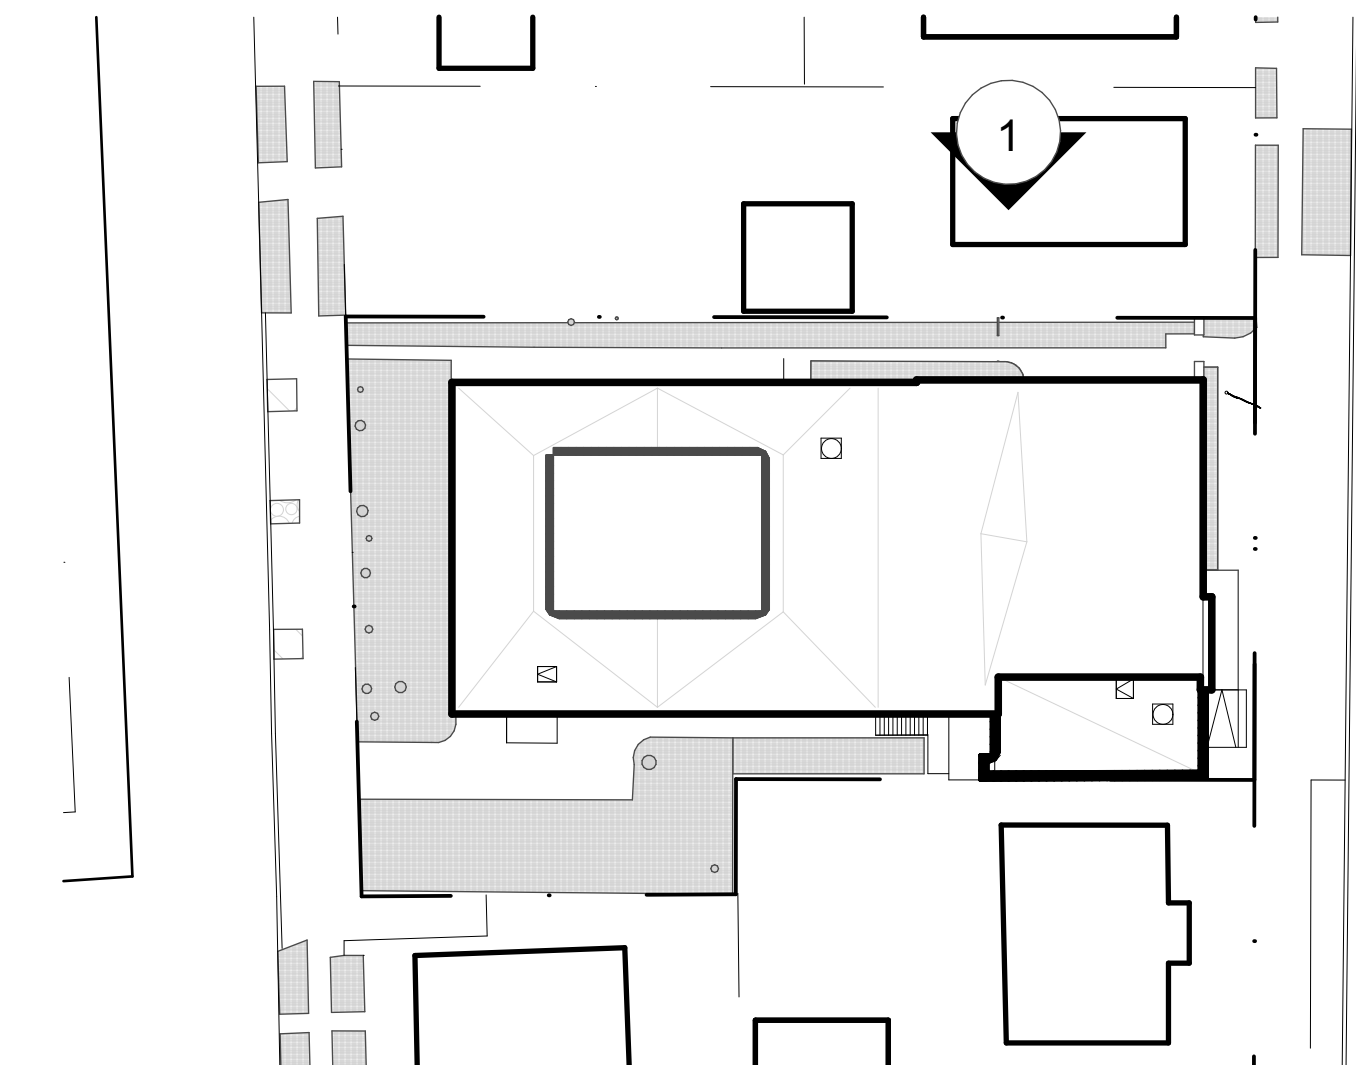

1 KEYPLAN  
NOT TO SCALE



2 PROPOSED SOUTH ELEVATION  
SCALE: 3/16" = 1'-0"


**WORK SCOPE**

- 1. STAIR AND ADA RAMP
- 2. ALUMINUM FRAMED WINDOWS
- 3. DOOR FROM LIBRARY TO GARDEN
- 4. BLUESTONE PAVERS



3 KEYPLAN  
NOT TO SCALE



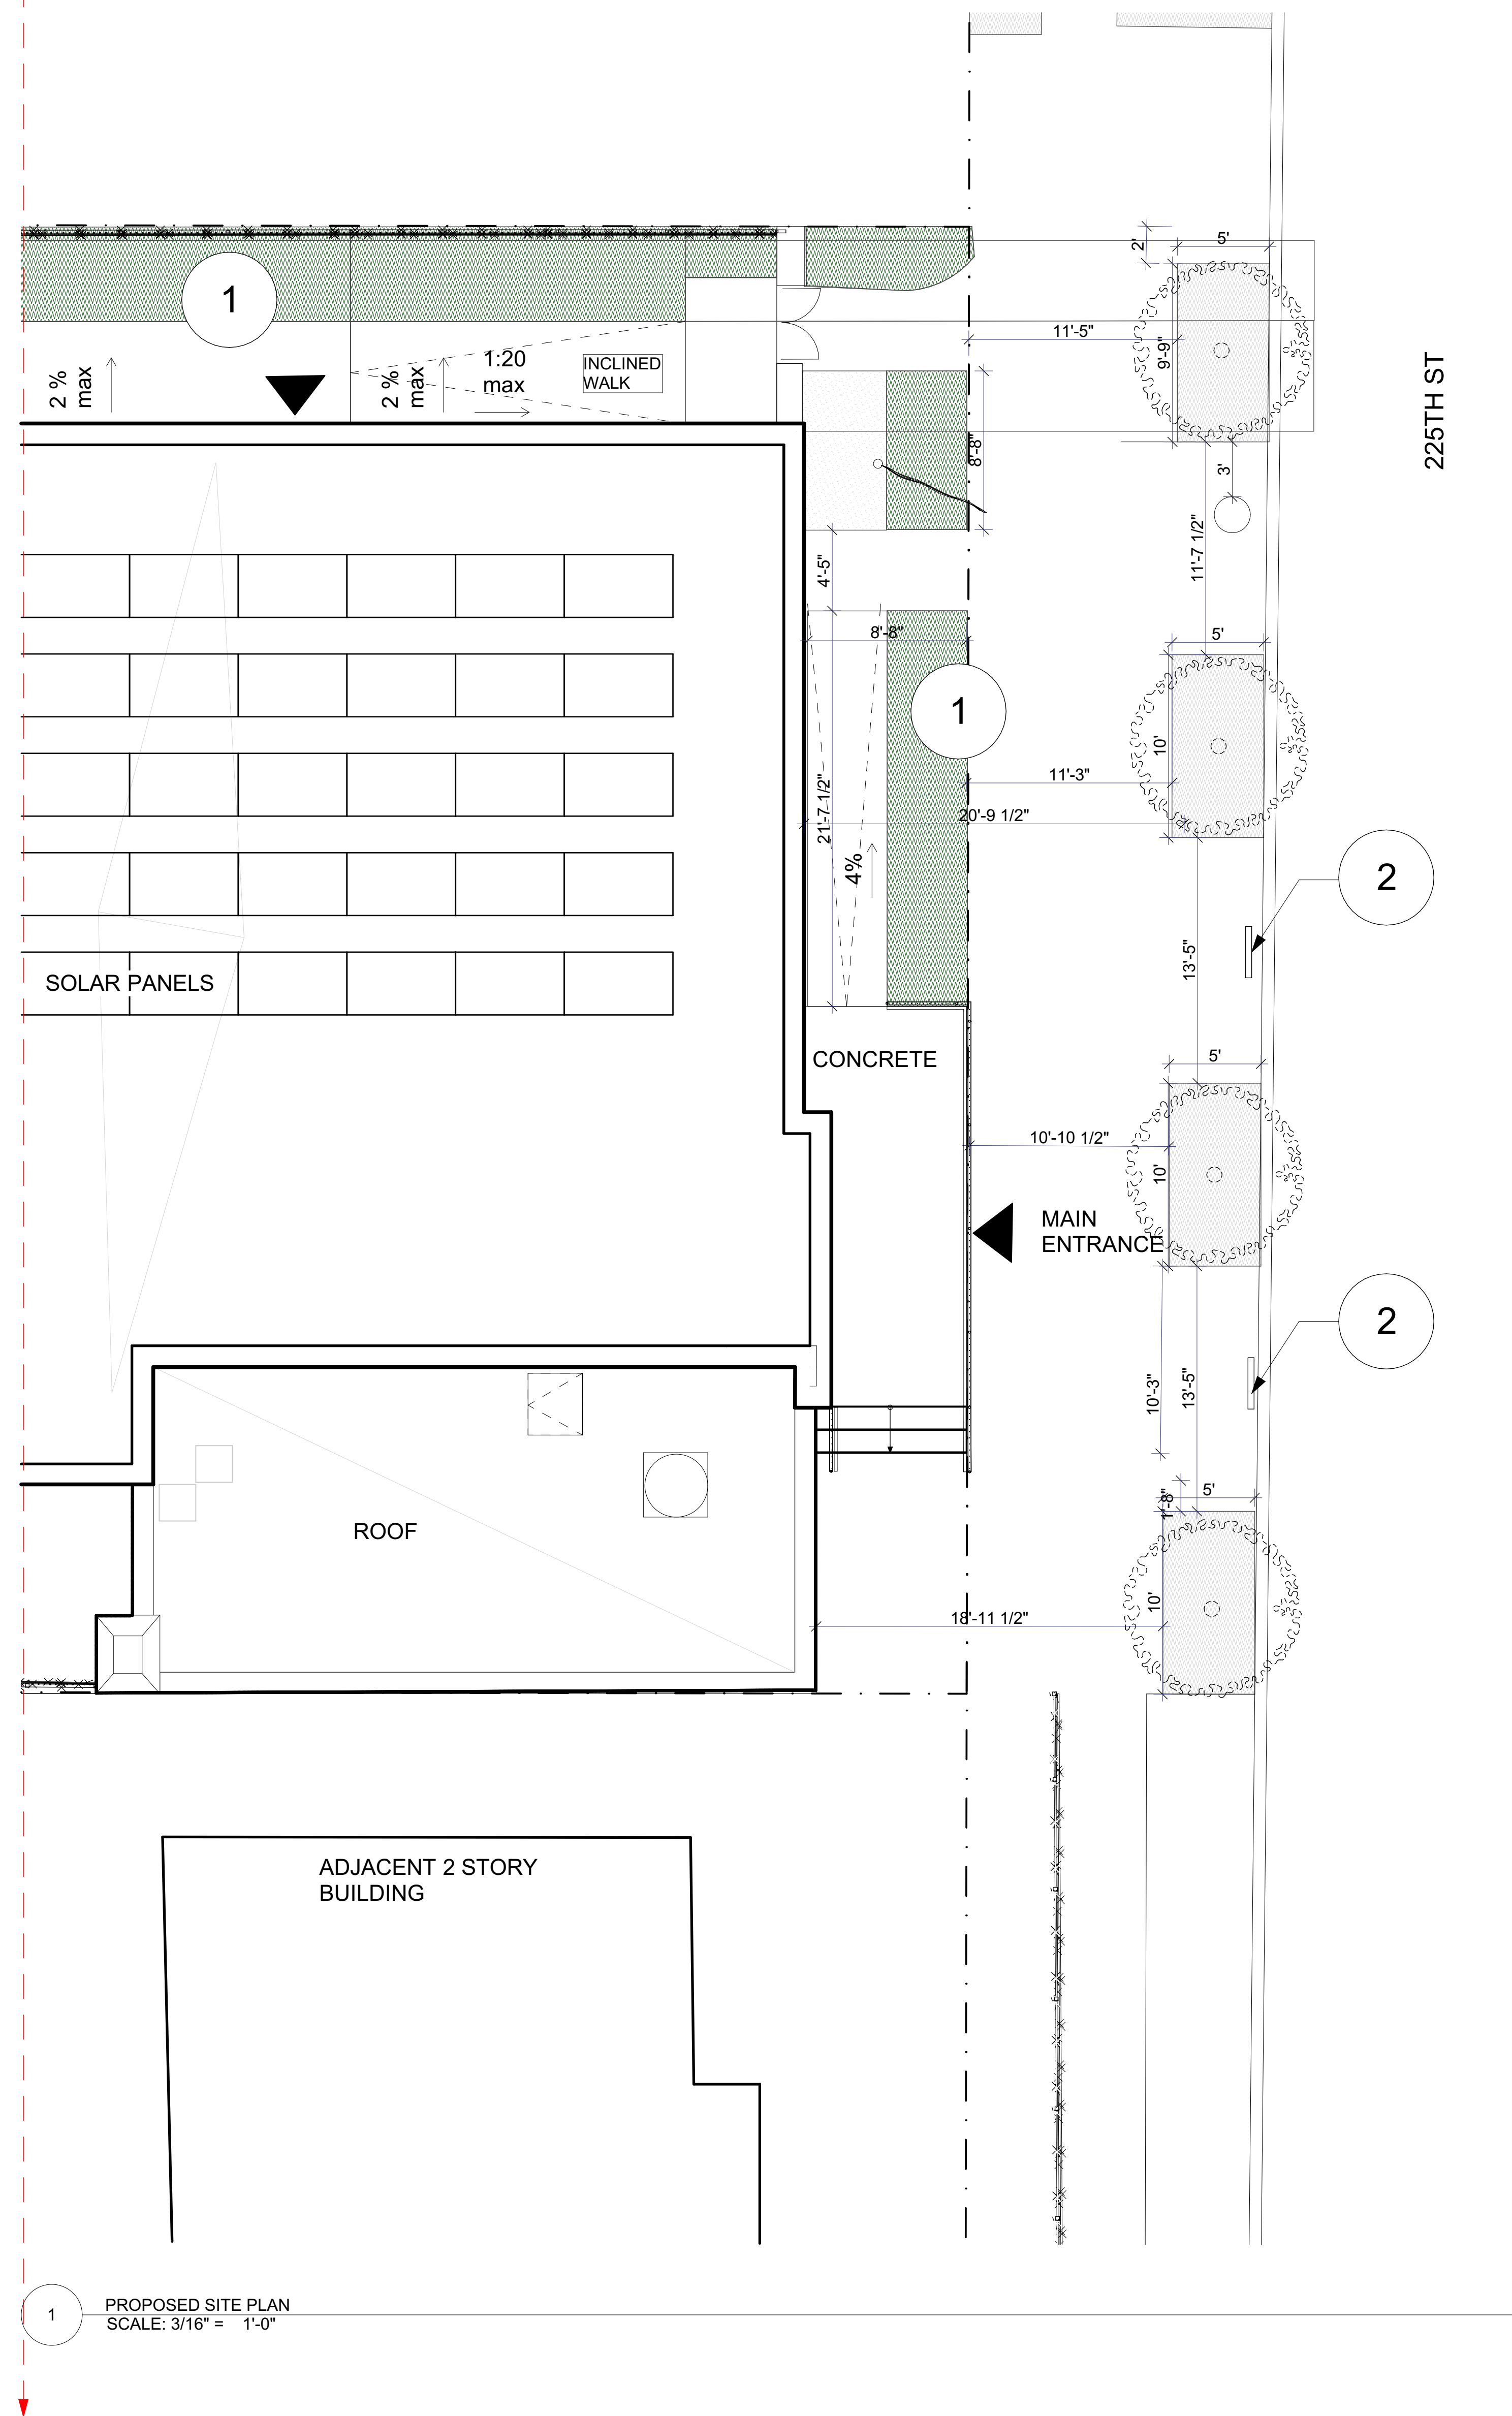


1 PACHYSANDRA TERMINALIS  
JAPANESE PACHYSANDRA  
4" O.C.



2 BIKE RACK



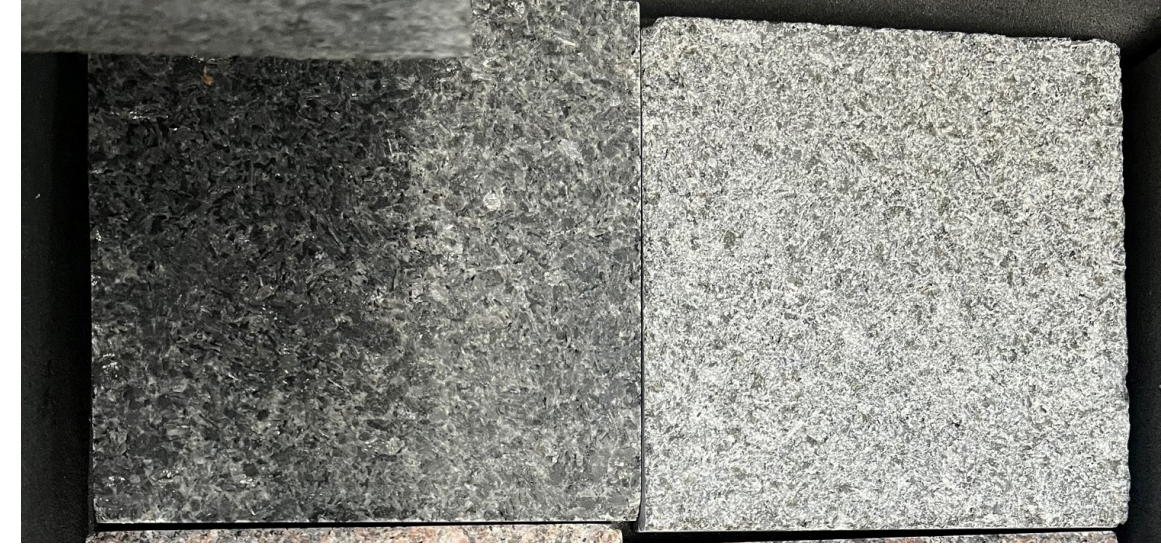


1 **Granite pavers**  
Superior Northern Thermal Finish  
Size: 2' x 4', can be 1" - 1-1/2" thick



2 **Steel Bar Fence - Black**



3 **Bench**

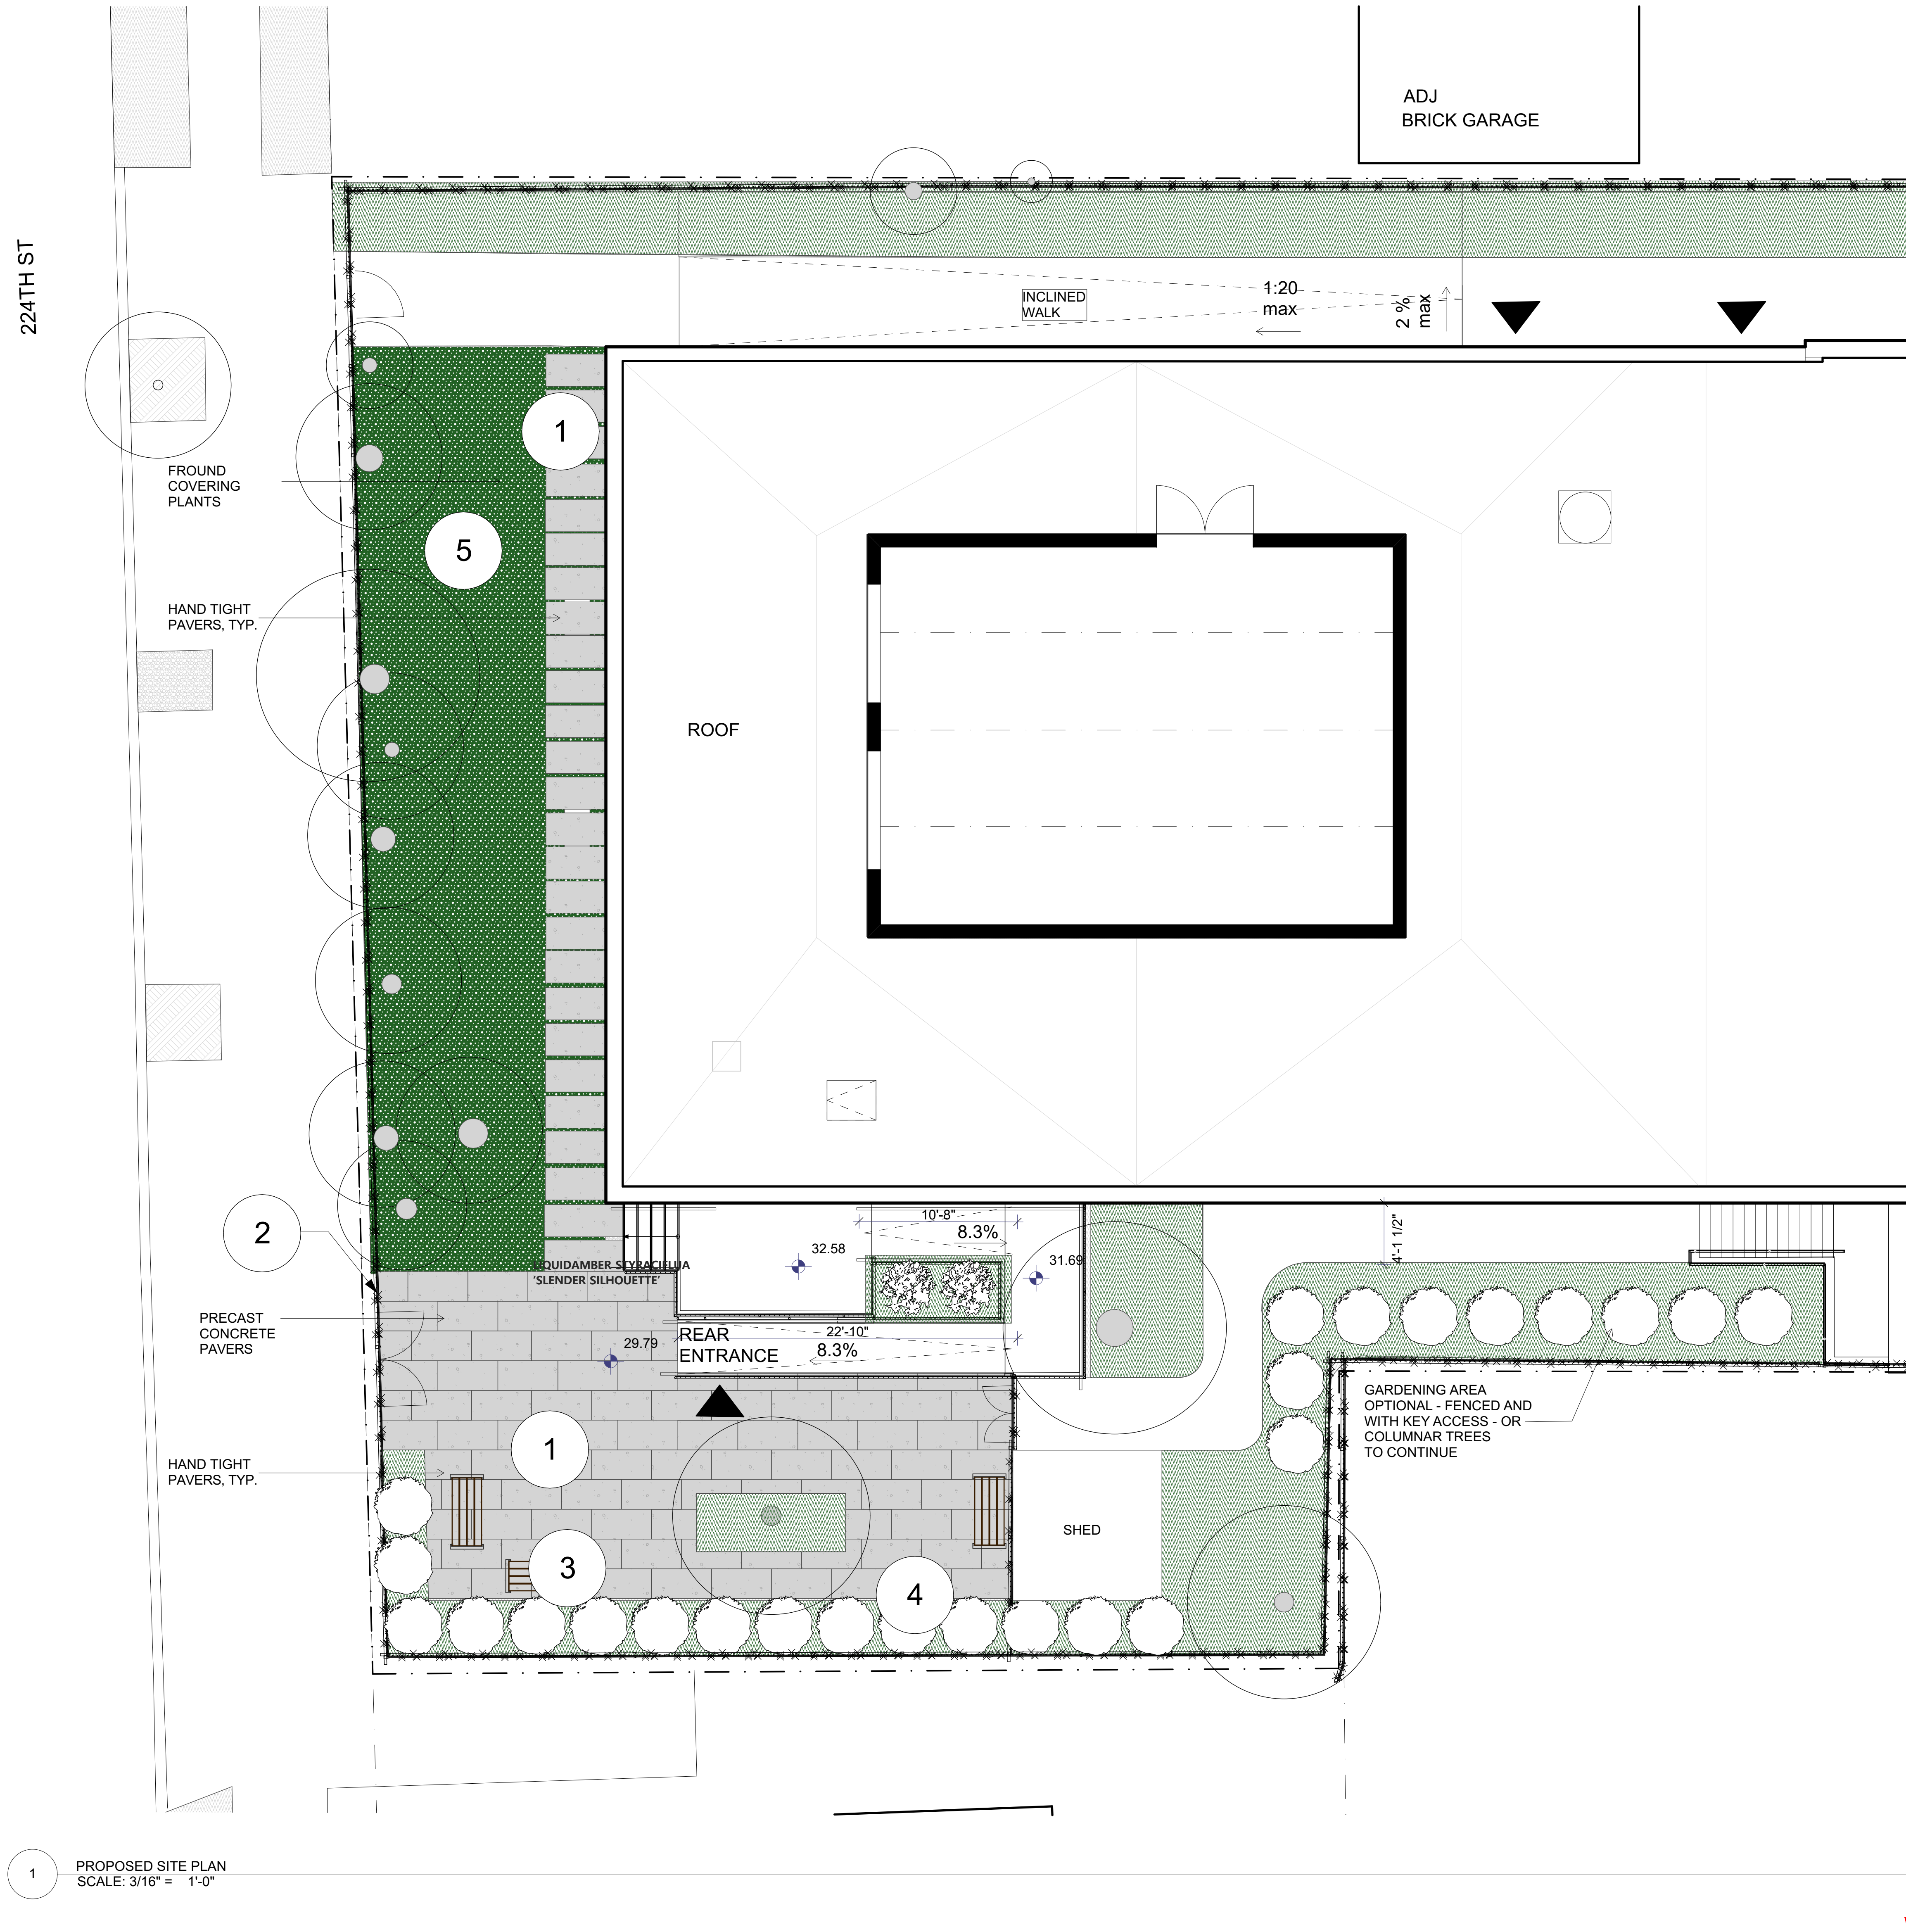

1 PROPOSED SITE PLAN  
SCALE: 3/16" = 1'-0"



4 **LIQUID AMBER STYRACIFLUA**  
'SLENDER SILHOUETTE'



5 **PACHYSANDRA TERMINALIS**  
JAPANESE PACHYSANDRA  
4" O.C.

**CONTACT INFORMATION:**

Anna Killion | Outreach Coordinator  
 Office of Communication and Policy, Public Buildings/Borough-Based Jails Program  
 NYC Department of Design and Construction  
 30-30 Thomson Avenue, 5-132, Long Island City, NY 11101  
 O: 718-391-1973 / C: 347-374-0930 / killionan@ddc.nyc.gov

Norberto Acevedo | Director  
 Office of Community Outreach & Notification (OCON), DDC  
 Phone - 7183912102 Mobile - 3472429371  
 aevedono@ddc.nyc.gov

**NEXT STEPS**

